

PROPOSED REFURBISHMENT AND ALTERATION

WORKS

FOR LAUTOKA LEGAL AID OFFICE

@ LAUTOKA.

Client:

LEGAL AID COMMISSION

Ministry of Public Works, Meteorological
Services & Transport

Department of Buildings & Government Architect

Architects Section

2025


PROJECT ARCH/OFFICER: V.CHAND
DRAWN: V.CHAND/ A.CIRIKIWAI
PROJECT: 23182

DRAWING SCHEDULE

ARCHITECTURAL DRAWING

A0.00	MAP OF VITILEVU
A0.01	LOCALITY PLAN
A0.02	SITE LOCALITY PLAN
A1.00	EXISTING FLOOR LAYOUT PLAN
A1.01	DEMOLITION PLAN
A1.02	PROPOSED FLOOR LAYOUT PLAN
A1.03	ELECTRICAL PLAN - POWERPOINTS
A1.04	REFERENCE PLAN
A2.00	TYPICAL SECTION X-X & Y-Y
A3.00	ALUMINIUM PARTITION FRAME DETAIL 1
A3.01	TYPICAL PARTITION FRAME DETAILS
A3.02	TIMBER PARTITION SECTIONAL ELEVATION & PLAN
A3.03	TEE JUNCTION & CORNER JUNCTION
A4.00	ENLARGED PLAN - RECEPTION COUNTER
A4.01	ENLARGED PLAN - OC'S ROOM
A4.02	ENLARGED PLAN - KITCHEN
A5.00	DOOR & IRONMONGERY SCHEDULE
A5.01	FINISHING SCHEDULE
A6.00	JOINERY DETAIL - RECEPTION COUNTER
A6.01	JOINERY DETAIL - IN-BUILT SINK BENCH, SHELVES & DRAWERS

Contractor The contractor must verify all dimensions on the drawing before the execution of work or shop drawings. Dimensions Figured dimensions shall take precedence over called dimensions and the largest scale drawing will take precedence. Copyright Copyright of all specifications, documentation and all work executed pertaining to these documents remains the sole property of the Government Architects of the Republic of Fiji. Contractor to comply with all relevant Standards & relevant Regulations.	Amendment <table><tr><td>no.</td><td>date</td></tr><tr><td> </td><td> </td></tr><tr><td> </td><td> </td></tr><tr><td> </td><td> </td></tr></table>	no.	date							drawn V.C./A.C. AS SHOWN approval C.TAWAKE	date 11 NOV 2024 V.CHAND DREGA approval A.PENE	proj./disc Proposed Refurbishment and Alteration Works For Lautoka Legal Aid Office @ Lautoka.	location no.	project no. 23182
		no.	date											
drawing title INDEX			sheet no.	sheet no.										
						amend								

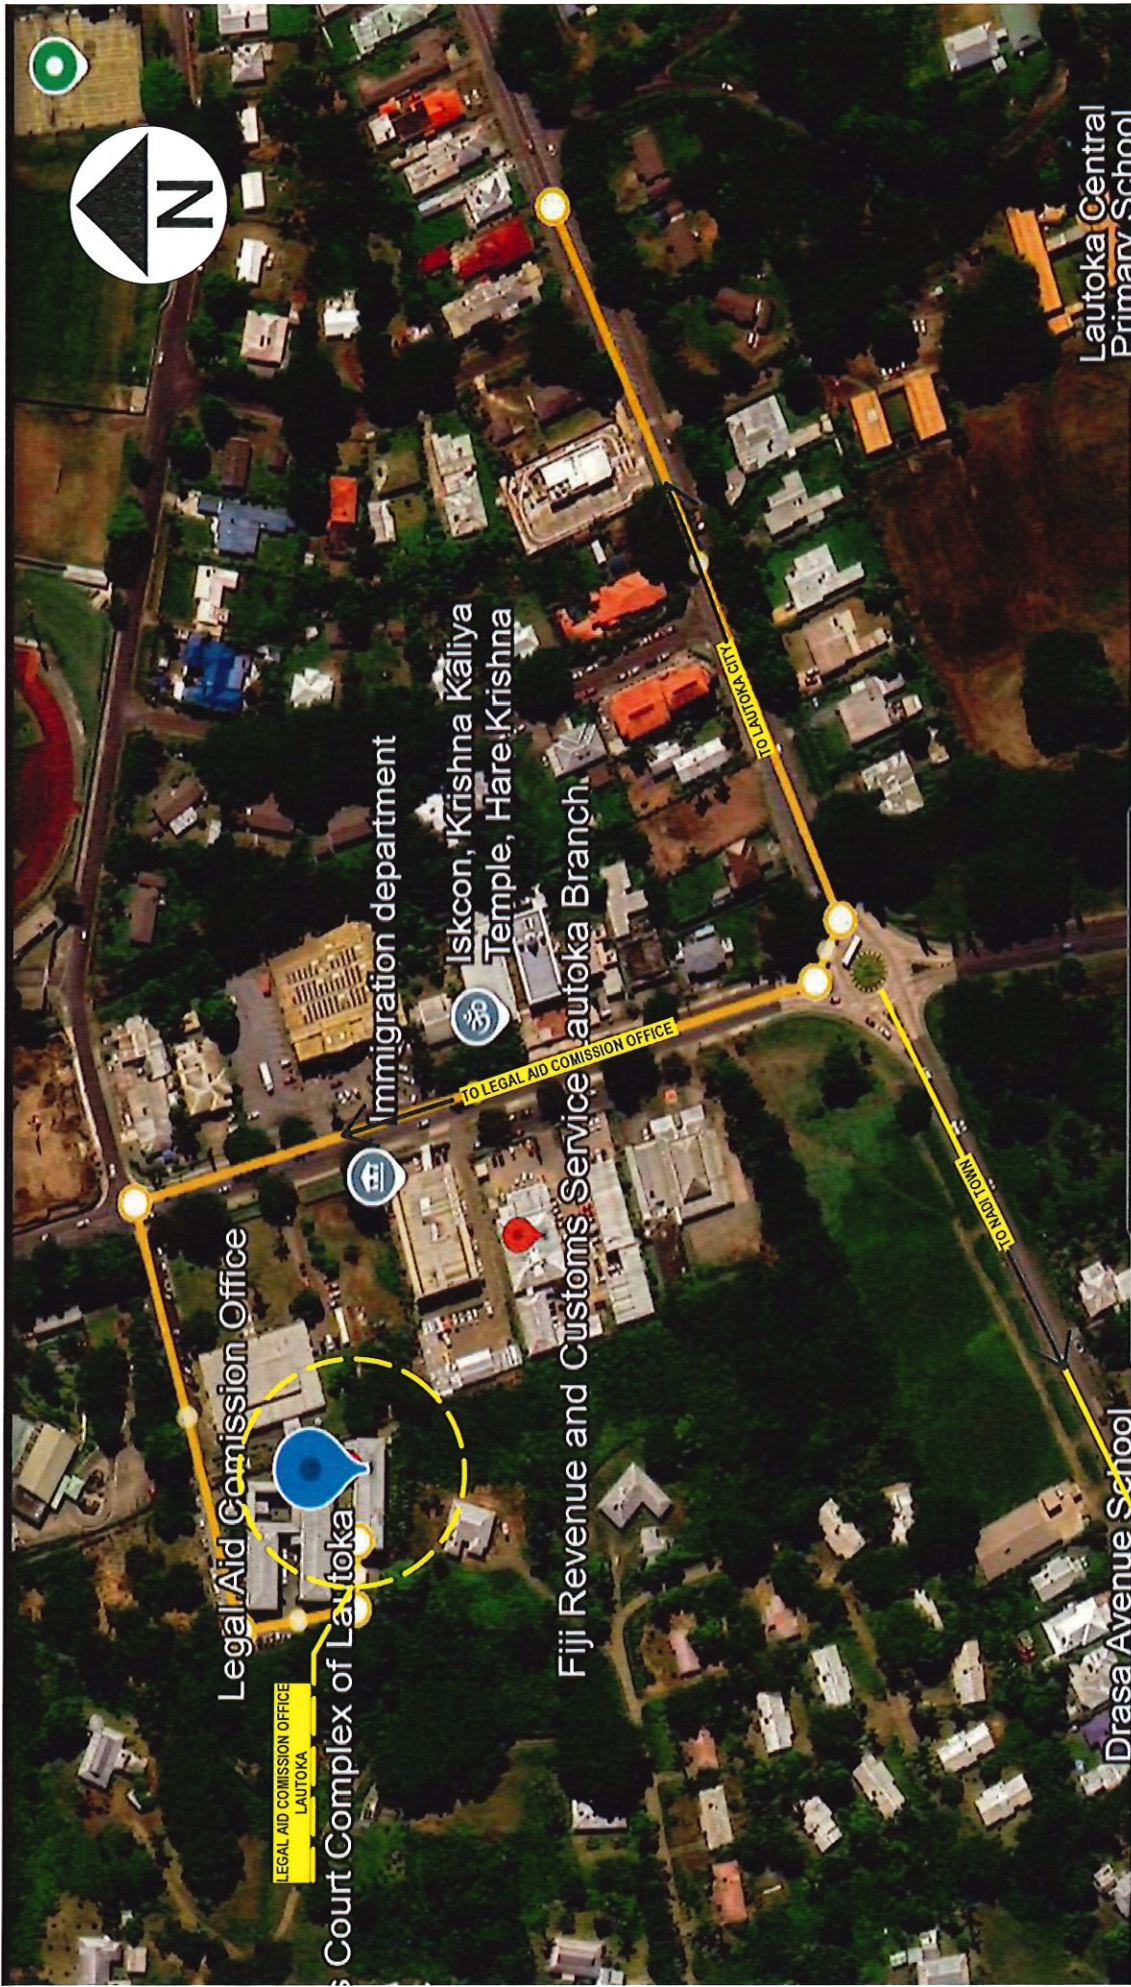

2 LOCALITY PLAN

Scale: NTS

Contractor		Amendment		Project no.		Location no.		Project no.	
The contractor must verify all dimensions on the drawing before the execution of work or shop drawings. The contractor shall notify the project architect of any discrepancies.		no.		date		date		23182	
Dimensions		date		V.C / A.C		11 NOV 2024		Proposed Refurbishment and Alteration Works For Lautoka Legal Aid Office @ Lautoka.	
Figured dimensions shall take preference over scaled dimensions and the largest scale drawing will take preference.		no.		scale: as shown		V.CHAND		Drawing title	
Copyright		date		approval		AS SHOWN		LOCALITY PLAN	
Copyright of all specifications, documentation and all work executed pertaining to these documents remains the sole property of the Government Architects of the Republic of Fiji.		date		C.TAWAKE		DB/GA approval		A0.01	
Contractor to comply with all relevant Standards & relevant Regulations.		date		MINISTRY OF PUBLIC WORKS		A.PENE		amend	



Fig.1 Allow to remove existing 100mm internal timber walls as shown dotted in demolition plan



Fig.2 Allow to remove all existing doors as shown dotted in demolition plan



Fig.3 Allow to remove all existing shelves, reception counter and sink bench as shown in demolition plan

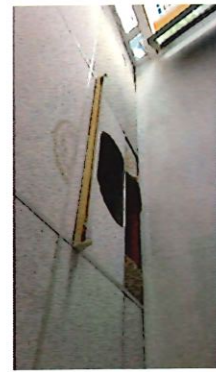
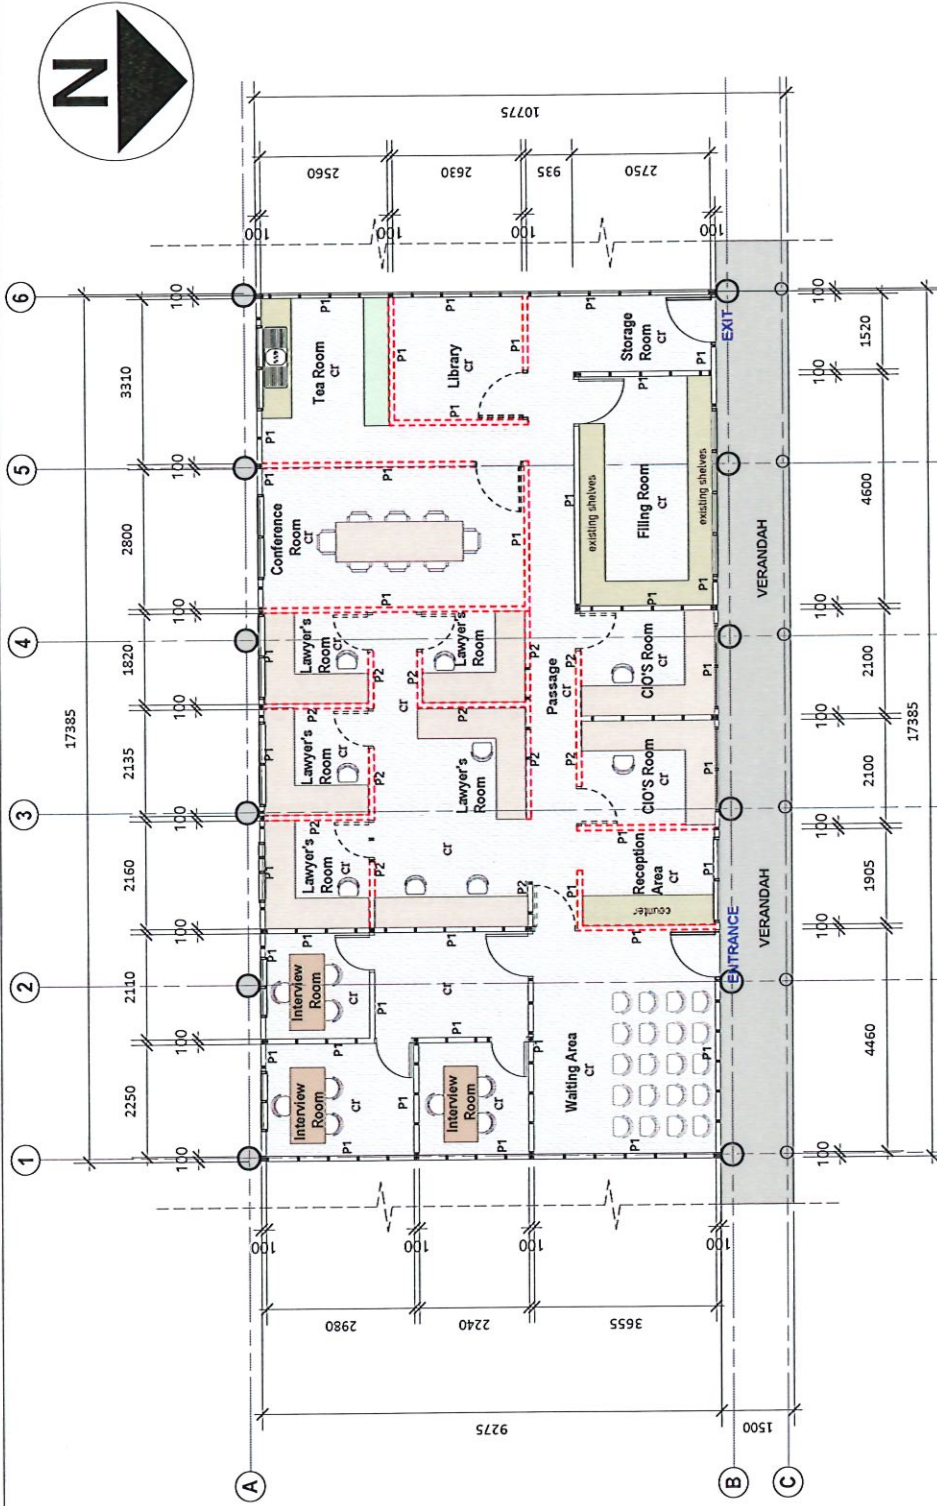


Fig.4 Allow to remove 5 no.s existing damaged suspended ceiling panels.

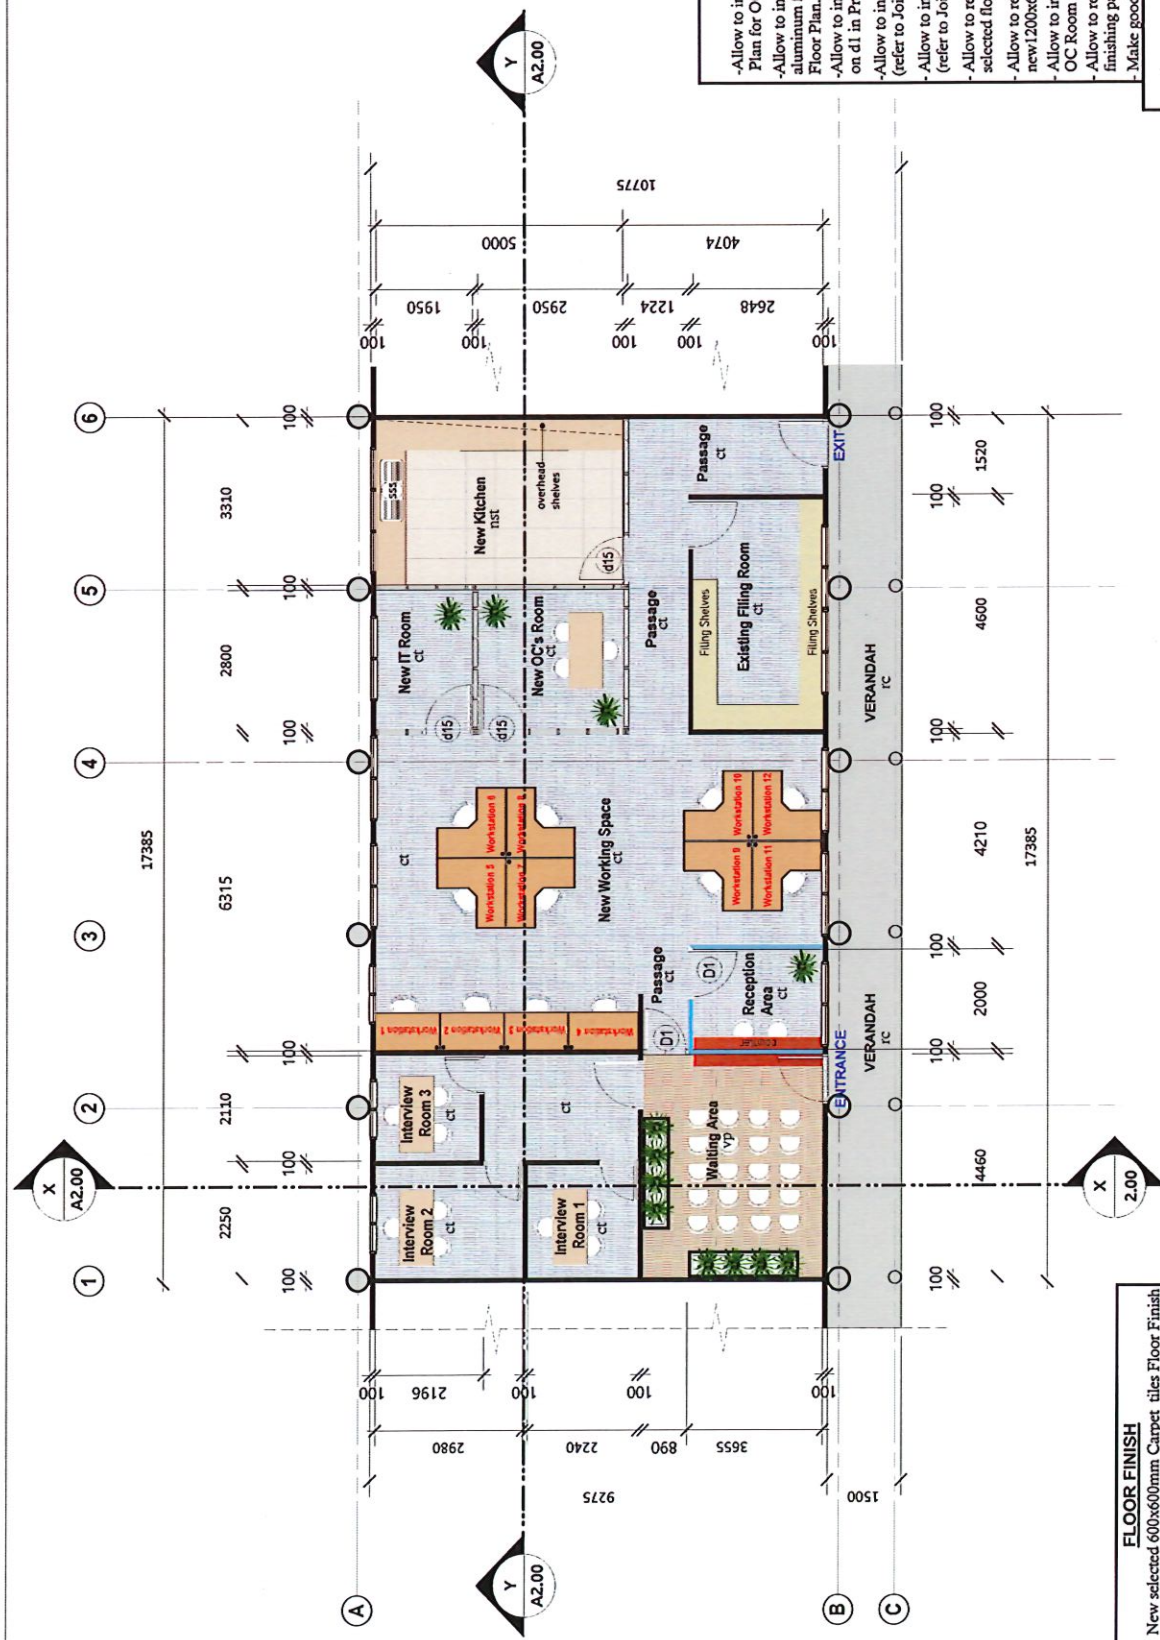


Fig.5 Allow to remove all existing floor carpet rugs



2 DEMOLITION PLAN
Scale: 1:100 @ A3

FLOOR FINISH cr Existing carpet rug floor finishing		SCOPE OF WORK - DEMOLITION - Allow to remove existing 100mm internal timber walls as shown dotted in demolition plan - Allow to remove all existing doors as shown dotted in demolition plan - Allow to remove existing reception counter and sink bench as shown in demolition plan - Allow to remove all existing floor carpet rugs - Allow to remove existing 5 no.s damaged suspended ceiling panels.	
WALL TYPE Existing 100mm/10mm thk. internal timber wall to be removed as shown dotted Existing 100mm thk. internal timber wall 2.4m high Existing 10mm thk. internal timber partition 1.5m high Existing 450mm dia. reinf. conc. column Existing 250mm dia. reinf. conc. column		Proposed Refurbishment and Alteration Works For Lautoka Legal Aid Office @ Lautoka.	
drawn by	V.C / A.C	date	11 NOV 2024
scale	as shown	proj. off	V.CHAND
approval	AS SHOWN	DBGA approval	A.PENE
Contractor must verify all dimensions on the drawing before the execution of work or shop drawings. The contractor shall notify the project architect of any discrepancies. Dimensions Figure dimensions shall take preference over scaled dimensions and the largest scale drawing will take preference. Copyright Copyright of all specifications, documentation and all work executed pertaining to these documents remains the sole property of the Government Architects of the Republic of Fiji. Contractor to comply with all relevant Standards & relevant Regulations.		MINISTRY OF PUBLIC WORKS	
Amendment no. detail		Project no. 23182 Revision no. A1.01 Sheet no. amend	



ct	New selected 600x600mm Carpet tiles Floor Finish
vp	New Vinyl Plank Floor Finish
nst	New 600 x 600 non-slip tiles floor finish
rc	Existing RC Floor

Contractor must verify all dimensions on the drawing before the execution of work or shop drawings. The contractor shall notify the project architect of any discrepancies.

Dimensions

Figured dimensions shall take preference over scaled dimensions and the largest scale drawing will take preference.

Copyright of all specifications, documentation and all work executed pertaining to these documents remains the sole property of the Government Architects of the Republic of Fiji.

Contractor to comply with all relevant Standards & relevant Regulations.

Scale: 1:100 @ A3

drawn	V.C / A.C	date	11 NOV 2024	proj./block	P
scale: as shown	AS SHOWN	proj. off	V.CHAND		F
approval	C.TAWAKE	DEGA approval	A.PENE	drawing title	F
- MINISTRY OF PUBLIC WORKS					


approval	C.TAWAKE	COO approval	A.PENE
----------	----------	--------------	--------

location no.	project no.
	23182

shoot no.	amend
A1.02	

- Allow to install new timber walls as shown in Proposed Plan for OC & IT Room.
- Allow to install new 10.38mm fixed glass with aluminium frame at Reception Area as shown on Proposed Floor Plan.
- Allow to install new aluminium frame glass door as shown on d1 in Proposed Floor Plan
- Allow to install new counter desk at Reception Area (refer to Joinery details)
- Allow to install new sink bench in new Kitchen (refer to Joinery details)
- Allow to replace existing floor carpets with new 600x600mm selected floor tiles as shown in the proposed floor plan
- Allow to replace damaged 5 nos of existing ceiling tiles with new 1200x600mm ceiling tiles.
- Allow to install new double power points at Working Space, OC Room and IT Room
- Allow to repaint existing internal walls with 2 coats of finishing paint to match existing.
- Make good to all damages

- New 100mm thk. timber partition with studs.
- New aluminium frames with 10.38mm fixed glass.
- Existing 100mm thk. timber wall partition.

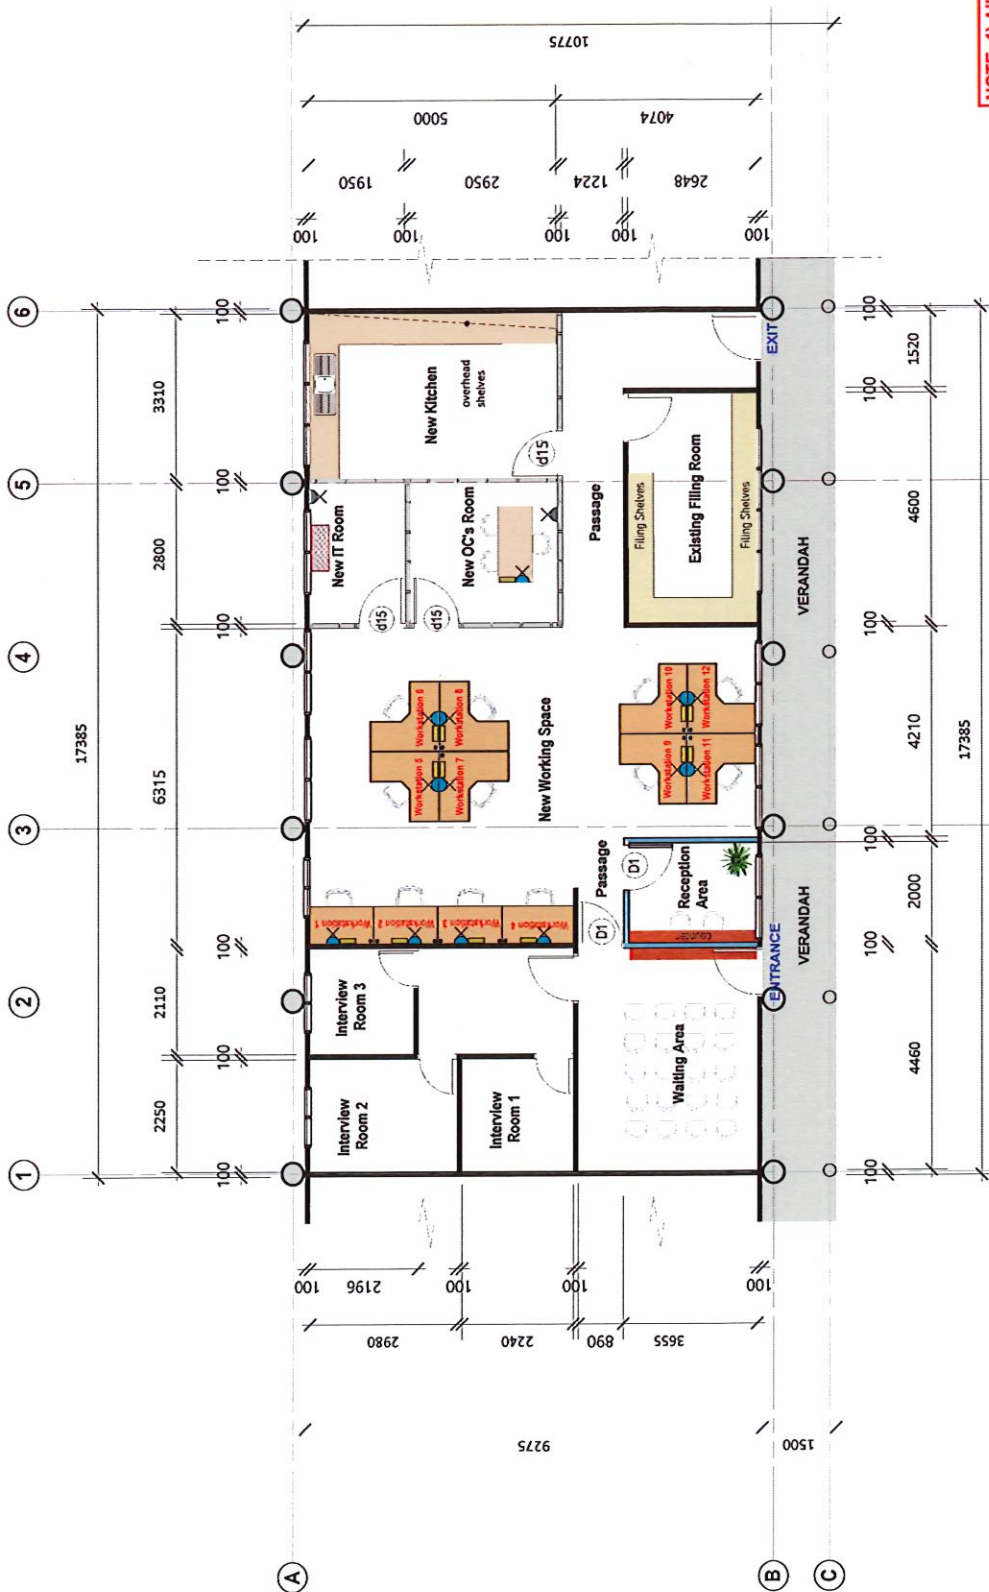

NOTE: 1) Allow to install ethernet mounting and powerpoints on every office desk
2) The Ceiling Lights to remain

ELECTRICAL LEGEND

-  -ethernet mounting box and double powerpoint
-  -double powerpoint with mounting box
-  -internet cable distribution board

location no.	project no.
	23182

shoot no. **A1.03** among

proj/block
Proposed Refurbishment and Alteration Works
For Lautoka Legal Aid Office @ Lautoka.

drawing title

ELECTRICAL PLAN - POWERPOINTS

amendment		no.	detail	date	drawn V.C / A.C. scale: as shown	11 NOV 2024	date
					AS SHOWN <td>V.CHAND<td>DSCA approval</td></td>	V.CHAND <td>DSCA approval</td>	DSCA approval
					approval <td>C.TAWAKE<td>A.PENE</td></td>	C.TAWAKE <td>A.PENE</td>	A.PENE
						MINISTRY OF PUBLIC WORKS	

Contractor
The contractor must verify all dimensions on the drawing before the execution of work or shop drawings. The contractor shall notify the project architect of any discrepancies.

Dimensions
Figured dimensions shall take preference over scaled dimensions and the largest scale drawing will take preference.


Copyright
Copyright of all specifications, documentation and all work executed pertaining to these documents remains the sole property of the Government Architect of the Republic of Fiji.

Revisions
Revisions shall be indicated by circled numbers and shall be subject to the approval of the project architect.

ELECTRICAL PLAN - POWERPOINTS

Scale: 1:100 @ A3


WALL TYPE	
	New 100mm thk. timber partition with studs.
	New aluminum frames with 10.38mm fixed glass.
	Existing 100mm thk. timber wall partition

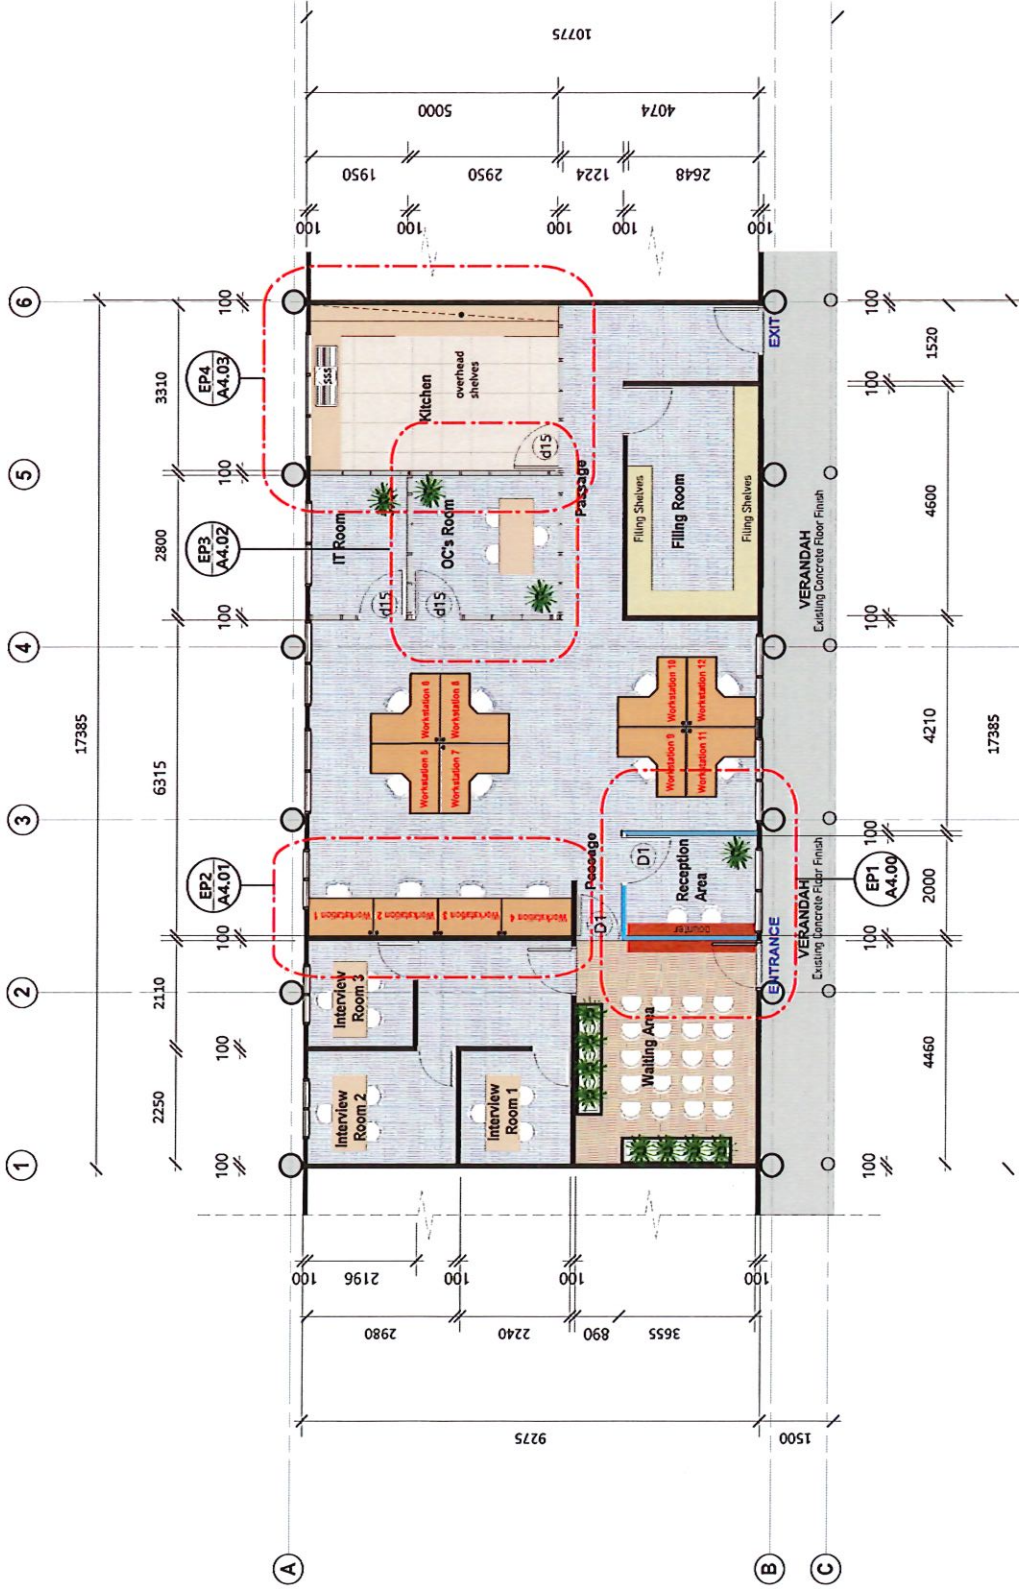


5 REFERENCE FLOOR PLAN

Scale: 1:100 @ A3

Contractor		Amendment		Project no.		Location no.		Sheet no.	
The contractor must verify all dimensions on the drawing before the execution of work or shop drawings.		no.		23182		23182		A1.04	
The contractor shall notify the project architect of any discrepancies.		detail		Proposed Refurbishment and Alteration Works		For Lautoka Legal Aid Office @ Lautoka.		amend	
Figured dimensions shall take preference over scaled dimensions and the largest scale drawing will take preference.		date		Drawing title		REFERENCE FLOOR PLAN			
Copyright		drawn		proj./block					
Copyright of all specifications, documentation and all work executed pertaining to these documents remains the sole property of the Government Architects of the Republic of Fiji.		V.C / A.C		date		11 NOV 2024			
Contractor to comply with all relevant Standards & relevant Regulations.		scale: as shown		proj. off		V.CHAND			
		date		approved		C.TAWAKE			
						DSCA approval			
						APENE			
						MINISTRY OF PUBLIC WORKS			

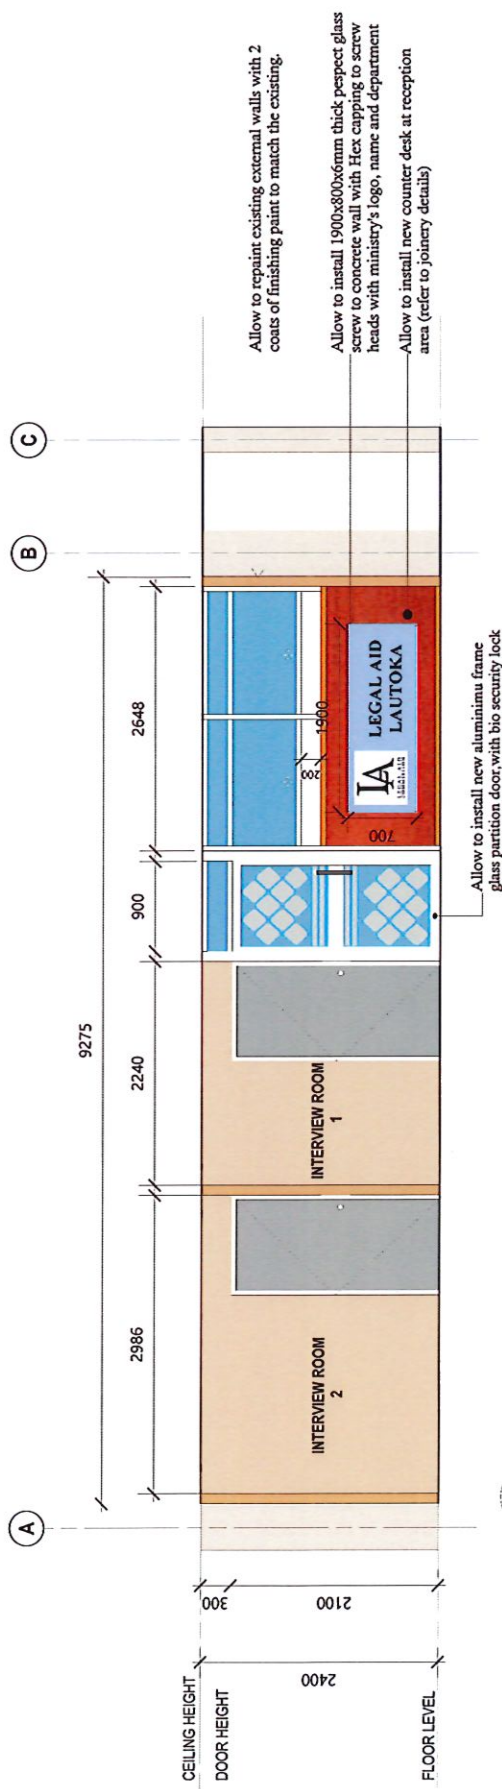

TYPICAL SECTION X-X

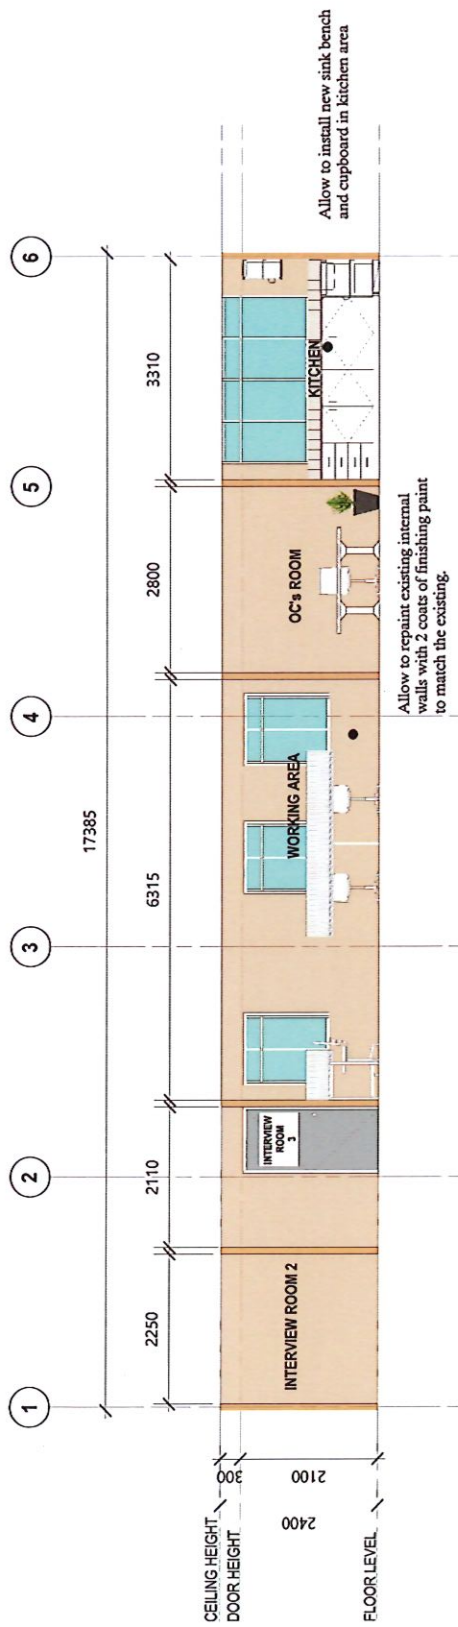

TYPICAL SECTION Y-Y

Amendment

Contractor
The contractor must verify all dimensions on the drawing before the execution of work or shop drawings.
The contractor shall notify the project architect of any discrepancies.
Dimensions
Figured dimensions shall take preference over scaled dimensions and the largest scale drawing will take preference.
Copyright
Copyright of all specifications documentation and all work executed pertaining to these documents remains the sole property of the Government Architect of the Republic of Fiji.
The contractor must comply with all relevant Standards & relevant Regulations.
The contractor to comply with all relevant Standards & relevant Regulations.

[illegible]



location no.

York

Section 1A






And Altern

and just

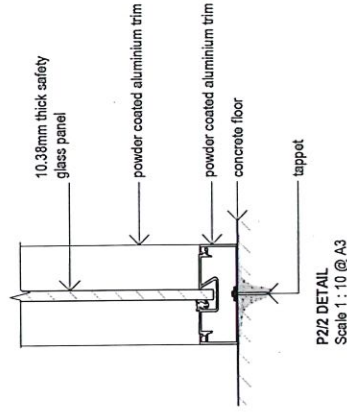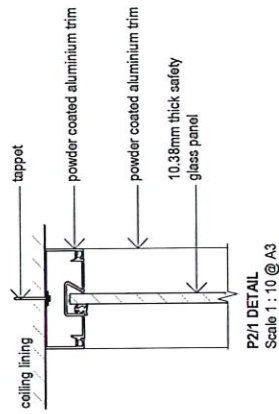


P2/2 DETAIL
Scale 1:10 @ A3

Contractor The contractor must verify all dimensions on the drawing before the execution of work or shop drawings. The contractor shall notify the project architect of any discrepancies. Dimensions Figured dimensions shall take preference over scaled dimensions and the largest scale drawing will take preference. Copyright: Copyright of all specifications, documentation and all work executed pertaining to these documents remains the sole property of the Government Architect of the Republic of Fiji. Contractor to comply with all relevant Standards & relevant Regulations.	Amendment		proj./block	location no.		project no.
			drawn	date	23182	
			V.C / A.C	11 NOV 2024		
			scale, as shown	scale, as shown		
			AS SHOWN	V.CHAND		
			approval	DBCA approval		
			C.TAWAKE	A.PENE		
			MINISTRY OF PUBLIC WORKS			
			ALUMINUM PARTITION SECTIONAL ELEVATION			
			drawing title			
			sheet no.			
			A3.00			
			amend			

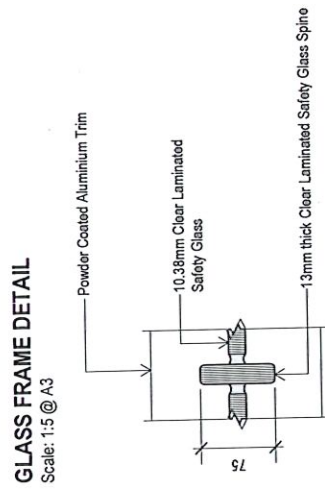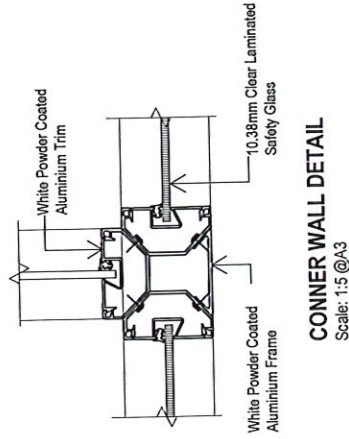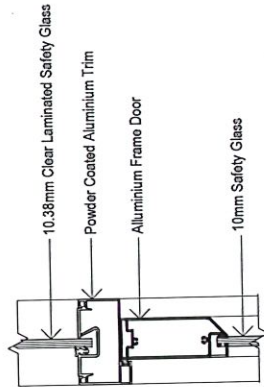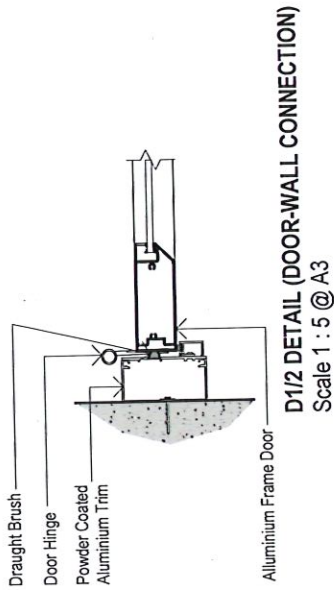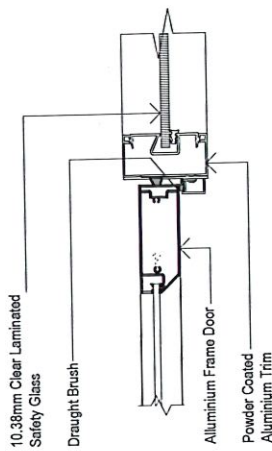


GLASS TO GLASS CONNECTION
Scale: 1:5 @ A3

Contractor The contractor must verify all dimensions on the drawing before the execution of work or shop drawings. The contractor shall notify the project architect of any discrepancies. Dimensions Figured dimensions shall take preference over scaled dimensions and the largest scale drawing will take preference. Copyright Copyright of all specifications, documentation and all work executed pertaining to these documents remains the sole property of the Government Architects of the Republic of Fiji. Contractor to comply with all relevant standards & relevant Regulations.	Amendment		drawn	date	proj./subproj.	location no.	project no. 23182	
			scale: as shown	11 NOV 2024	Proposed Refurbishment and Alteration Works For Lautoka Legal Aid Office @ Lautoka.			
	no. detail		AS SHOWN	V.CHAND	drawing title	sheet no.		
			approval	DBCA approval				
			C.TAWAKE	A.PENE			A3.01	amend
			MINISTRY OF PUBLIC WORKS					






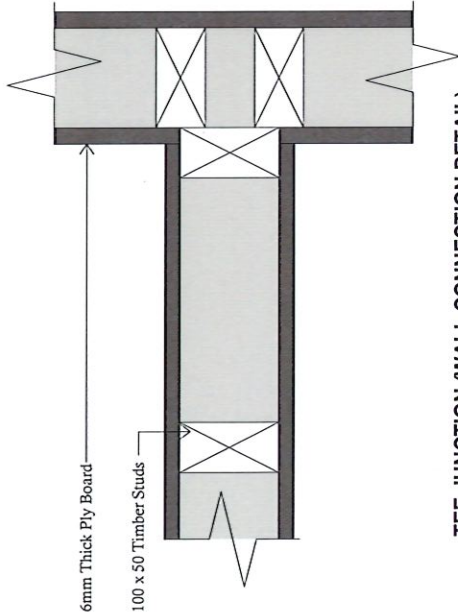


TEE JUNCTION (WALL CONNECTION DETAIL)
Scale: 1:5 @ A3

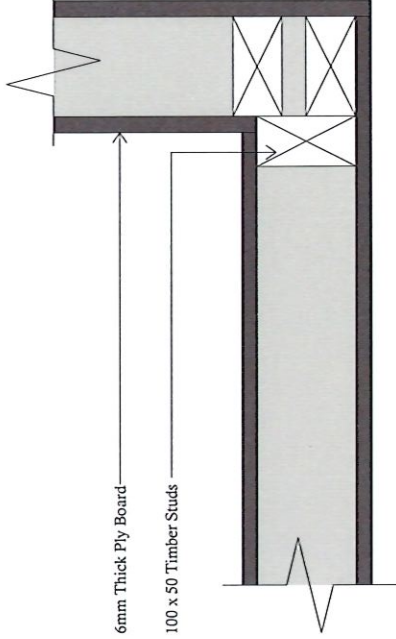

CORNER JUNCTION (WALL CONNECTION DETAIL)
Scale: 1:5 @ A3


Contractor The contractor must verify all dimensions on the drawing before the execution of work or shop drawings. The contractor shall notify the project architect of any discrepancies.		Amendment no. detail		drawn V.C / A.C scale: as shown AS SHOWN	date 11 NOV 2024	proj./block Proposed Refurbishment and Alteration Works For Lautoka Legal Aid Office @ Lautoka.	location no.	project no. 23182
Dimensions Figured dimensions shall take preference over scaled dimensions and the largest scale drawing will take preference.				approved C.TAWAKE	proj. off V.CHAND			
Copyright Copyright of all specifications, documentation and all work executed pertaining to these documents remains the sole property of the Government Architects of the Republic of Fiji. Contractor to comply with all relevant Standards & relevant Regulations.				DESIGN (signature) A.PENE			sheet no. A3.03	amend
				TEE JUNCTION & CORNER JUNCTION				

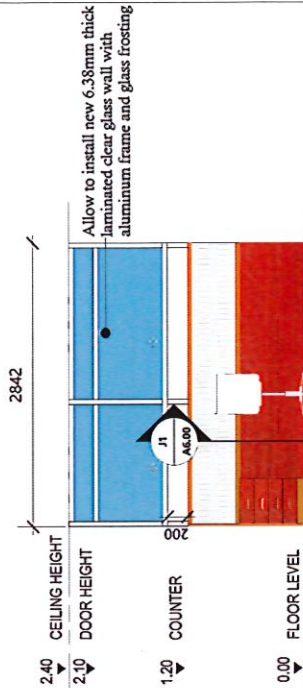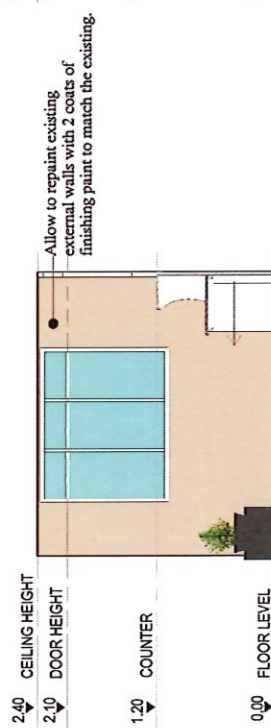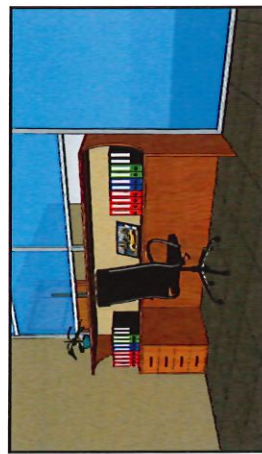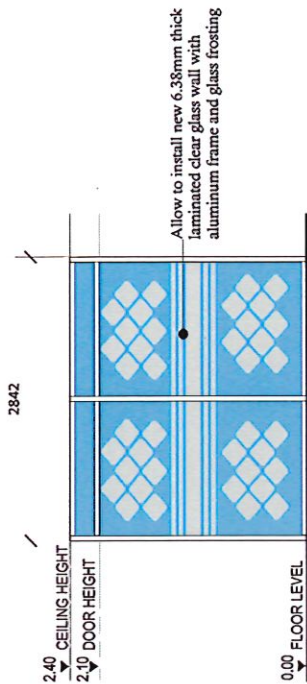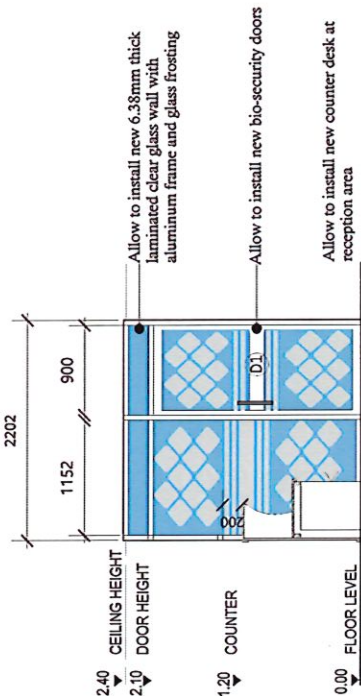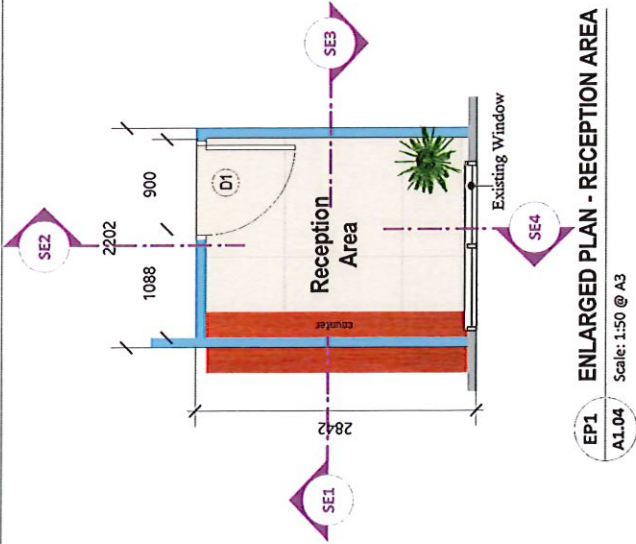

Contractor
The contractor must verify all dimensions on the drawing before the execution of work or shop drawings.
The contractor shall notify the project architect of any discrepancies.
Dimensions
Figured dimensions shall take preference over scaled dimensions and the largest scale drawing will take preference.
Copyright
Copyright of all specifications, documentation and all work executed pertaining to these documents remains the sole property of the Government Architects of the Republic of Fiji.
Contractor to comply with all relevant Standards & relevant Regulations.


Amendment	drawn	date	proj./book	location no.	project no.
no.	V.C / A.C	11 NOV 2024			23182
date	scale: as shown	proj. off			
detail	AS SHOWN	V.CHAND			
	approval	DBCA approval			
	C.TAWAKE	A.PENE			
	MINISTRY OF PUBLIC WORKS				
	ENLARGED PLAN - RECEPTION AREA				
					A4.00
					around

Proposed Refurbishment and Alteration Works
For Lautoka Legal Aid Office @ Lautoka.

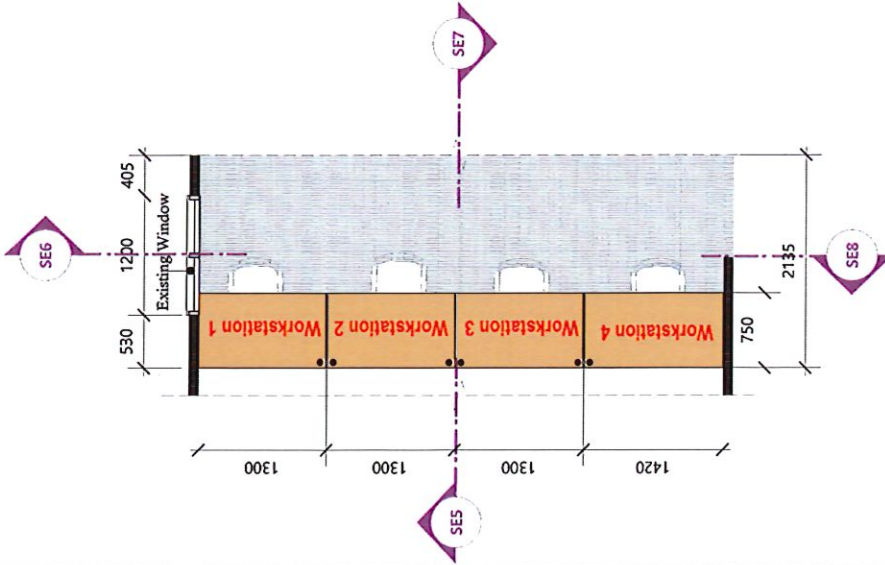

EP2 ENLARGED PLAN - NEW WORK STATIONS

A1.04 Scale: 1:50 @ A3

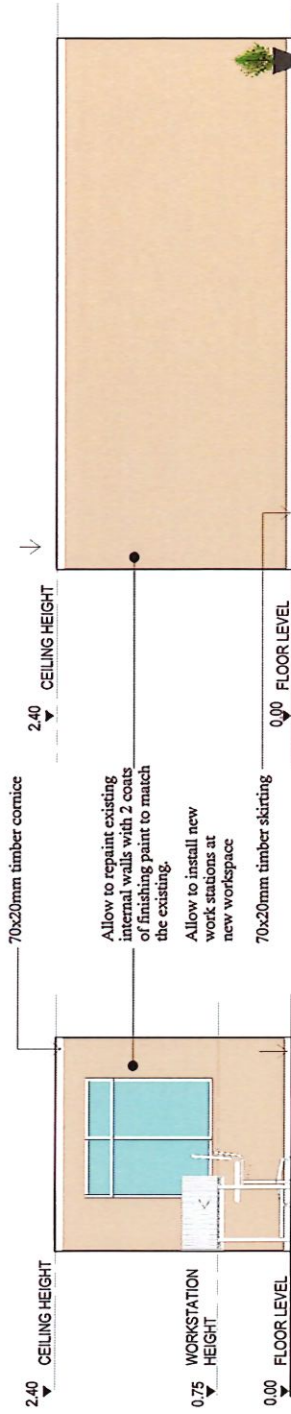


SE5 SECTIONAL ELEVATION SE5

Scale: 1:50 @ A3

SE6 SECTIONAL ELEVATION SE6

Scale: 1:50 @ A3

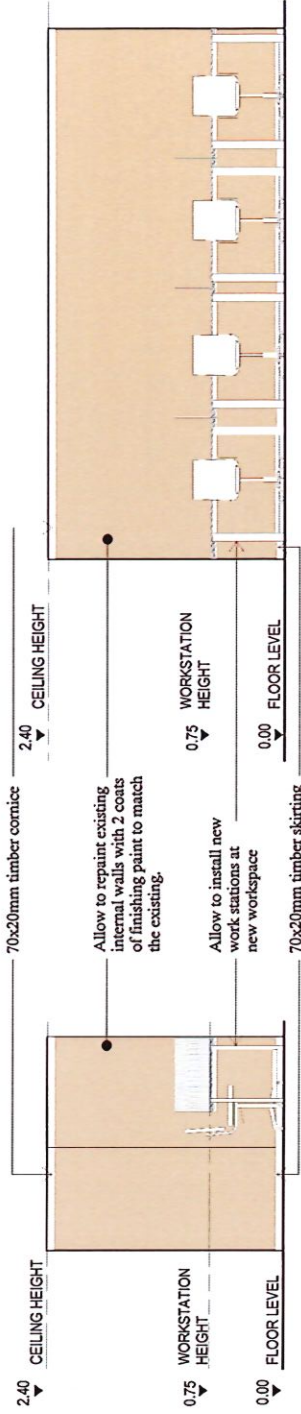

SE7 SECTIONAL ELEVATION SE7

Scale: 1:50 @ A3

SE8 SECTIONAL ELEVATION SE8

Scale: 1:50 @ A3

Contractor
The contractor must verify all dimensions on the drawing before the execution of work or shop drawings.
The contractor shall notify the project architect of any discrepancies.
Dimensions
Figured dimensions shall take preference over scaled dimensions and the largest scale drawing will take preference.
Copyright
Copyright of all specifications, documentation and all work executed pertaining to these documents remains the sole property of the Government Architect of the Republic of Fiji.
Contractor to comply with all relevant Standards & relevant Regulations.

Amendment

no.	date	drawn	date	proj./sheet
		V.C / A.C	11 NOV 2024	
		scale: as shown	proj. off	
		AS SHOWN	V.CHAND	
		approval	DBCA approval	
		C.TAWAKE	A.PENE	
			MINISTRY OF PUBLIC WORKS	

Proposed Refurbishment and Alteration Works
For Lautoka Legal Aid Office @ Lautoka.

location no.


project no.
23182

sheet no.





A4.01

ENLARGED PLAN - NEW WORK STATIONS


amount

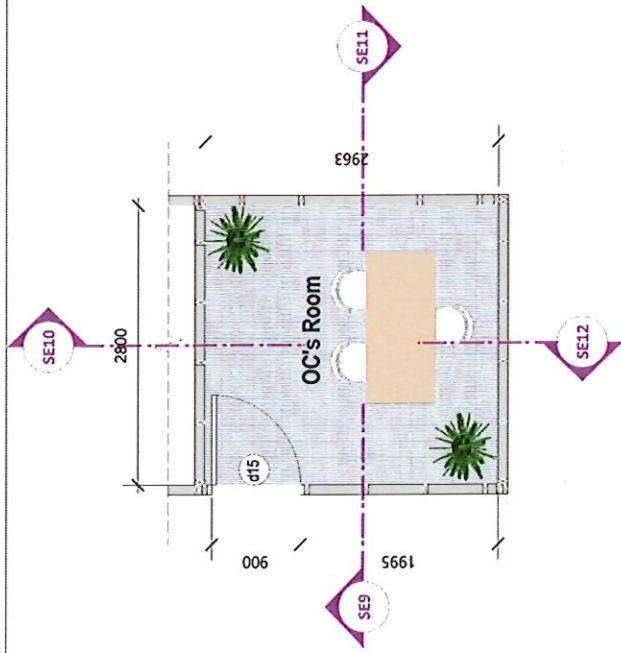


EP3
A1.04
ENLARGED PLAN - OC'S ROOM
Scale: 1:50 @ A3

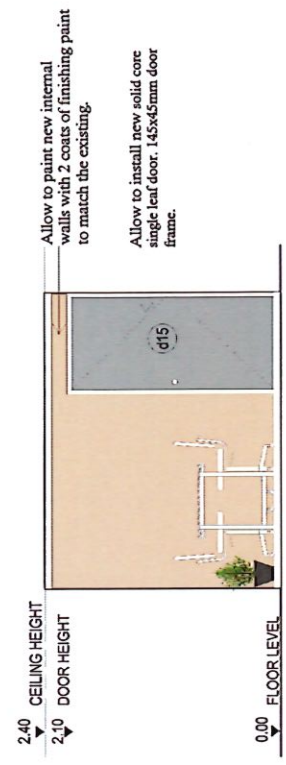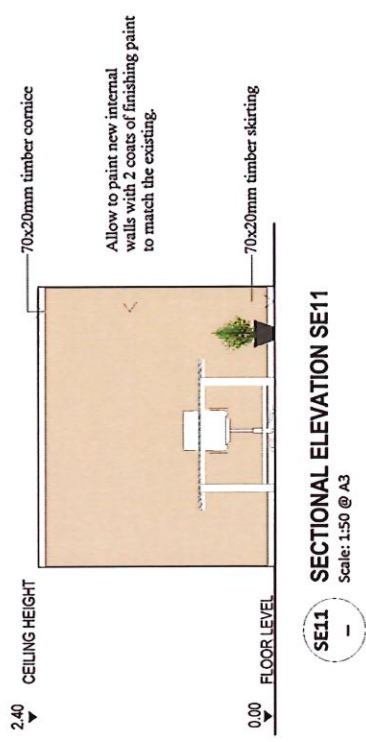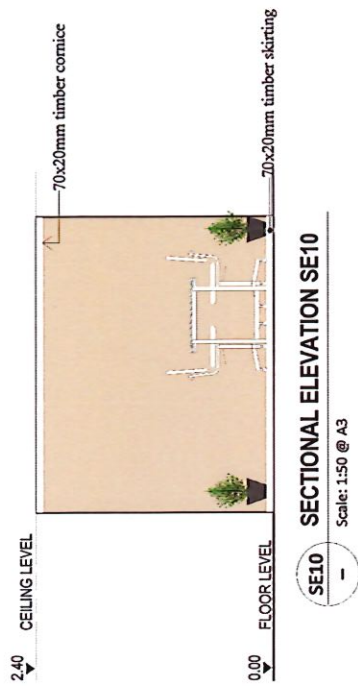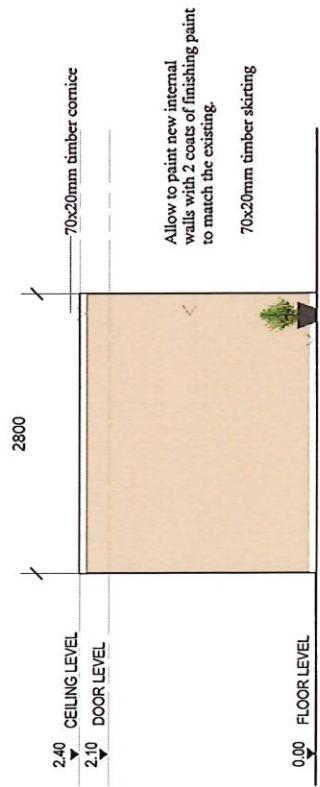

Contractor		The contractor must verify all dimensions on the drawing before the execution of work or shop drawings.		Amendment	
Dimensions		The contractor shall notify the project architect of any discrepancies.		No. detail	
Figured dimensions shall take preference over scaled dimensions and the largest scale drawing will take preference.		Copyright		Copyright of all specifications, documentation and all work executed pertaining to these documents remains the sole property of the Government Architects of the Republic of Fiji.	
Contractor to comply with all relevant Standards & relevant Regulations.		drawn		date	
V.C / A.C		11 NOV 2024		proj/blk	
scale: as shown		proj: off		location no.	
AS SHOWN		V.CHAND		project no.	
C.TAWAKE		APENE		sheet no.	
C.TAWAKE		APENE		23182	
MINISTRY OF PUBLIC WORKS		PROPOSED REFURBISHMENT AND ALTERATION WORKS FOR LAUTOKA LEGAL AID OFFICE @ LAUTOKA.		A4.02	
		ENLARGED PLAN - OC'S ROOM		amend	

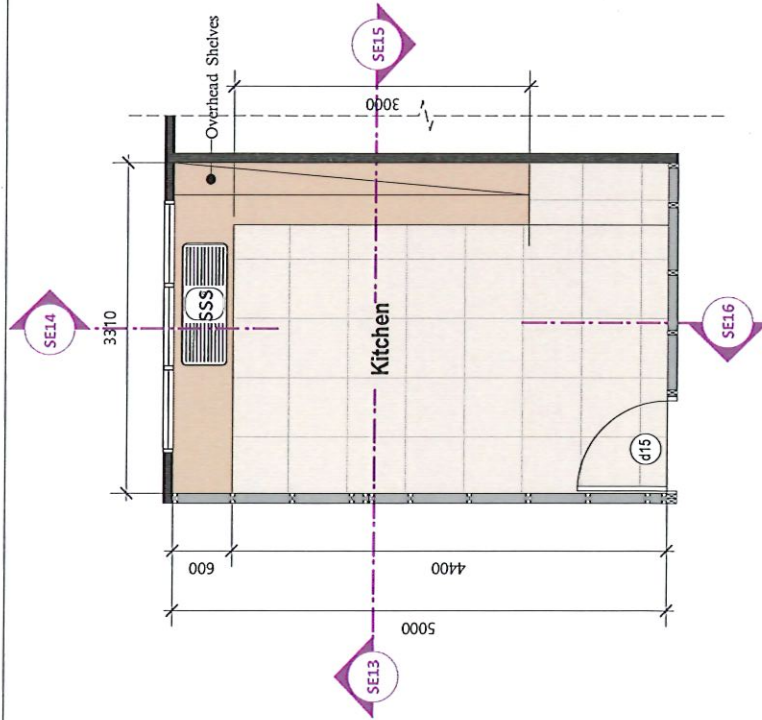

EP4 ENLARGED PLAN - KITCHEN
Scale: 1:50 @ A3

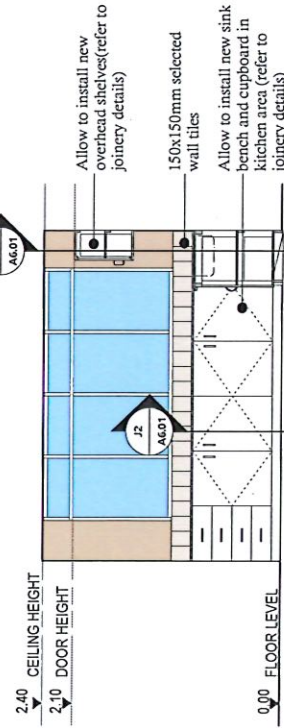


SE13 SECTIONAL ELEVATION SE13
Scale: 1:50 @ A3

Contractor
The contractor must verify all dimensions on the drawing before the execution of work or shop drawings.
Dimensions
The contractor shall rectify the project architect of any discrepancies.
Figured dimensions shall take preference over scaled dimensions and the largest scale drawing will take preference.
Copyright
Copyright of all specifications, documentation and all work executed pertaining to these documents remains the sole property of the Government Architects of the Republic of Fiji.
Contractor to comply with all relevant Standards & relevant Regulations.


NOTE: Allow for new stainless steel sink tap and allow to use existing pipe lines

drawn	date	proj./back
V.C / A.C	11 NOV 2024	
scale: as shown	prel. off	
AS SHOWN	V. CHAND	
approval	UBCA approval	
C. TAWAKE	A. PENE	
MINISTRY OF PUBLIC WORKS		

proposed	location no.	project no.
Proposed Refurbishment and Alteration Works For Lautoka Legal Aid Office @ Lautoka.		23182
drawing title	sheet no.	amend
ENLARGED PLAN - KITCHEN	A4.03	amend

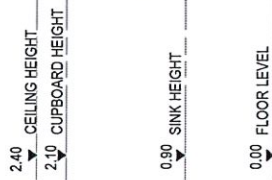


SE14 SECTIONAL ELEVATION SE14
Scale: 1:50 @ A3

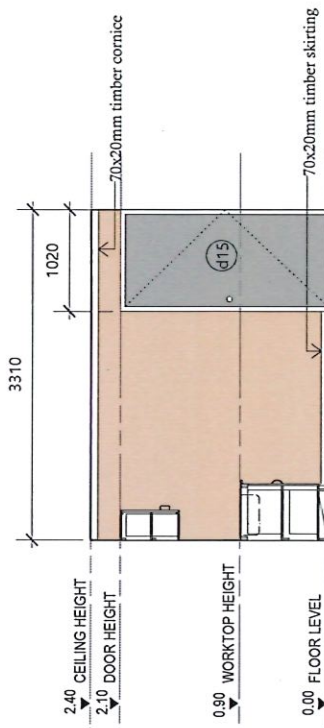

SE15 SECTIONAL ELEVATION SE15
Scale: 1:50 @ A3



SE16 SECTIONAL ELEVATION SE16
Scale: 1:50 @ A3

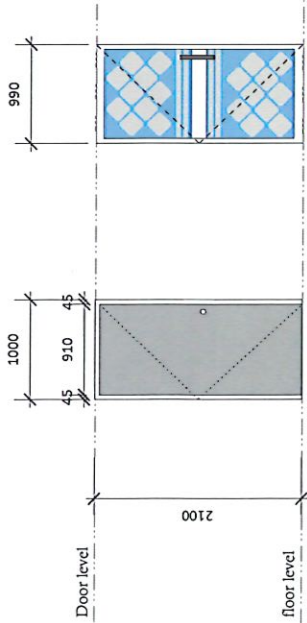

Door Type - d15
no. required (3 off)
solid core single leaf
door, 145x45mm door
frame

Door Type - D1
no. required (2 off)
aluminium frame
glass partition door,
with bio security lock

1 DOOR SCHEDULE

Scale: 1:50 @ A3

DOOR NO.	LOCATION	ITEMS	QUANTITY PER DOOR	REMARKS
D1	Front Securities	Parliament Hinge shiny round shape stainless steel pipe glass door handles	6 no.s	Stainless Steel
(2 nos.)		A350SC Floor Mounted Door Stopper	2 no.s	Stainless Steel
		Pensla Aluminium Door Closer	2 no.s	Satin Chrome
		Security Biometric Fingerprint Door Lock For Glass Door	2 no.s	Aluminum
		pull push signs for doors	2 no.s	
d15	Internal Rooms	Parliament Hinge shiny round shape stainless steel pipe glass door handles	9 no.s	Stainless Steel
(3 nos.)		A350SC Floor Mounted Door Stopper	3 no.s	Stainless Steel
		Pensla Aluminium Door Closer	3 no.s	Satin Chrome
		pull push signs for doors	3 no.s	Aluminum

2 IRONMONGERY SCHEDULE

Scale: NTS



Contractor
The contractor must verify all dimensions on the drawing before the execution of work or shop drawings.
The contractor shall notify the project architect of any discrepancies.
Dimensions
Figured dimensions shall take preference over scaled dimensions and the largest scale drawing will take preference.
Copyright
Copyright of all specifications, documentation and all work executed pertaining to these documents remains the sole property of the Government Architects of the Republic of Fiji.
Contractor to comply with all relevant Standards & relevant Regulations.

Amendment

No.	Detail

drawn	date	proj./check
V.C / A.C	11 NOV 2024	
scale: as shown	proj. off	
AS SHOWN	V.CHAND	
approval	DATE: 11/11/2024	
C.TAWAKE	A.PENE	
MINISTRY OF PUBLIC WORKS		

location no.	project no.
	23182
sheet no.	amend
A5.00	
DOOR & IRONMONGERY SCHEDULE	
Proposed Refurbishment and Alteration Works For Lautoka Legal Aid Office @ Lautoka.	

1.0	INTERIOR	SEALER	ZINC CHROMATE PRIMER	PINK PRIMER	METAL PRIMER	GALVO ONE	UNDER COAT	ACRYLIC	ENAMEL	TREATED	ROOF PAINT	POLYURETHANE	STAIN	VARNISH	BASE MATERIAL	COLOUR	NO. OF COATS	COLOR REF. No.	REMARKS
1.1	CEILING														PLY BOARD	WHITE	3	00 E 55	NA
1.2	DOORS & WINDOW FRAMES (BOTH SIDES)														TIMBER	WHITE	3	00 E 55	
1.3	DOORS - TIMBER														TIMBER	PEARL LUSTA	3	10 B 15	
1.4	ARCHITRAVES & TIMBER STOPS														TIMBER	HUSK	3	10 C 35	
1.5	CORNICE														TIMBER	MUSTARD	3	10 C 37	
1.6	SKIRTING														TIMBER	MUSTARD	3	10 C 37	
1.7	TIMBER WALLS														PLASTER	PEARL LUSTA	3	10 B15	NA
1.8	FLOOR, CARPET														PLASTER				NEW CARPET TILE FLOOR FINISH; CLIENT TO SELECT.
1.9	TIMBER SHELVING														TIMBER	CLEAR VARNISH	3		
1.10	CUPBOARD/SINK UNIT (EXPOSING FRAMING & DOORS)														TIMBER	CLEAR VARNISH	3		

3

FINISHING SCHEDULE

Scale: NTS

Contractor

The contractor must verify all dimensions on the drawing before the execution of work or shop drawings.

Dimensions

The contractor shall verify the project architect of any discrepancies.

Figured dimensions shall take preference over scaled dimensions and the largest scale drawing will take preference.

Copyright

Copyright of all specifications, documentation and all work executed pertaining to these documents remains the sole property of the Government Architects of the Republic of Fiji.

Contractor to comply with all relevant Standards & relevant Regulations.

Amendment

no. 1

date

drawn

V.C / A.C

scale as shown

AS SHOWN

approval

C.TAWAKE

MINISTRY OF PUBLIC WORKS

date

11 NOV 2024

Prep. of

V.CHAND

DBCA approval

A.PENE

proj./back

Proposed Refurbishment and Alteration Works

For Lautoka Legal Aid Office @ Lautoka.

drawing title

FINISHING SCHEDULE

location no.

23182


sheet no.

A5.01

amend




Cabinet Hinge

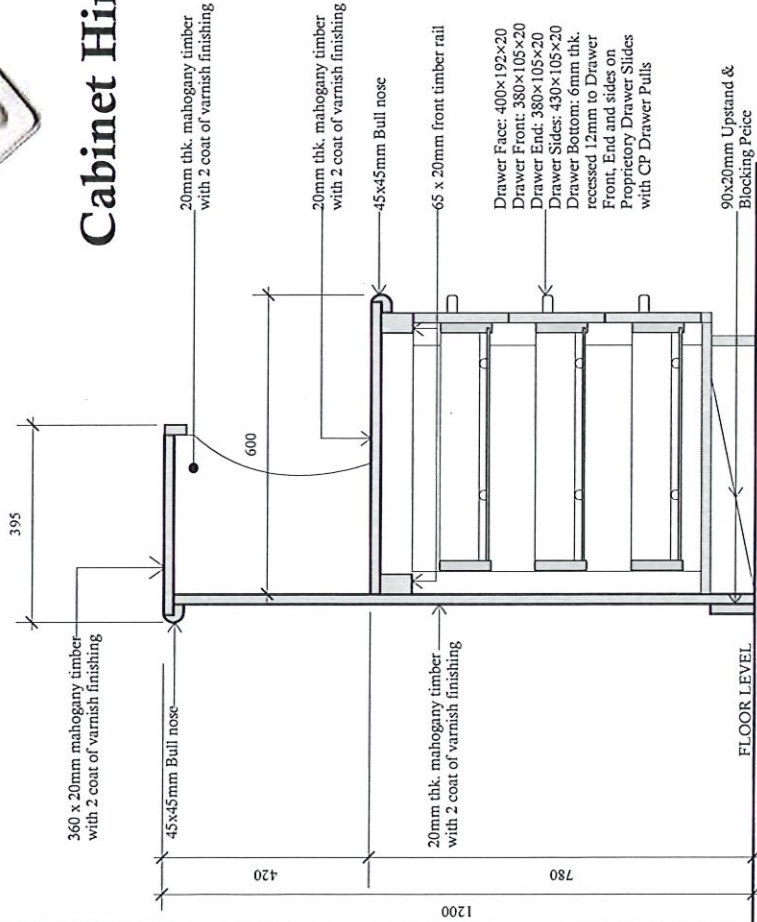

J1 JOINERY DETAIL - RECEPTION COUNTER
Scale: 1:10



Cabinet Door Handle

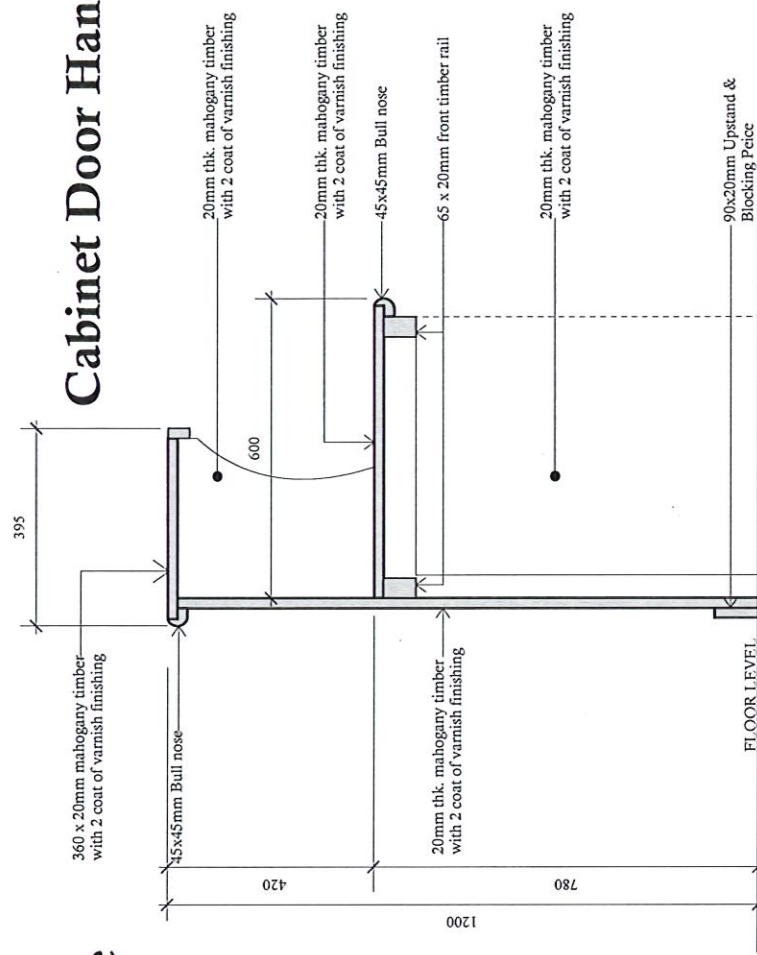

J1 JOINERY DETAIL - RECEPTION COUNTER
Scale: 1:10



Contractor		Amendment		Project no.		23182	
The contractor must verify all dimensions on the drawing before the execution of work or shop drawings.				Location no.			
Dimensions				Drawing title		Proposed Refurbishment and Alteration Works For Lautoka Legal Aid Office @ Lautoka.	
Figured dimensions shall take preference over scaled dimensions and the largest scale drawing will take preference.		no. detail		drawing title			
Copyright		date		date			
Copyright of all specifications, documentation and all work executed pertaining to these documents remains the sole property of the Government Architects of the Republic of Fiji.		V.C / A.C		11 NOV 2024			
Contractor to comply with all relevant Standards & relevant Regulations.		scale as shown		proj. off			
		AS SHOWN		V.CHAND			
		approval		DECA approval			
		C.TAWAKE		A.PENE			
				MINISTRY OF PUBLIC WORKS			

NOTES:
ALL TIMBER FRAMES ARE SCREW FIXED INTO WALLS



Cabinet Door Handle

Cabinet Hinge

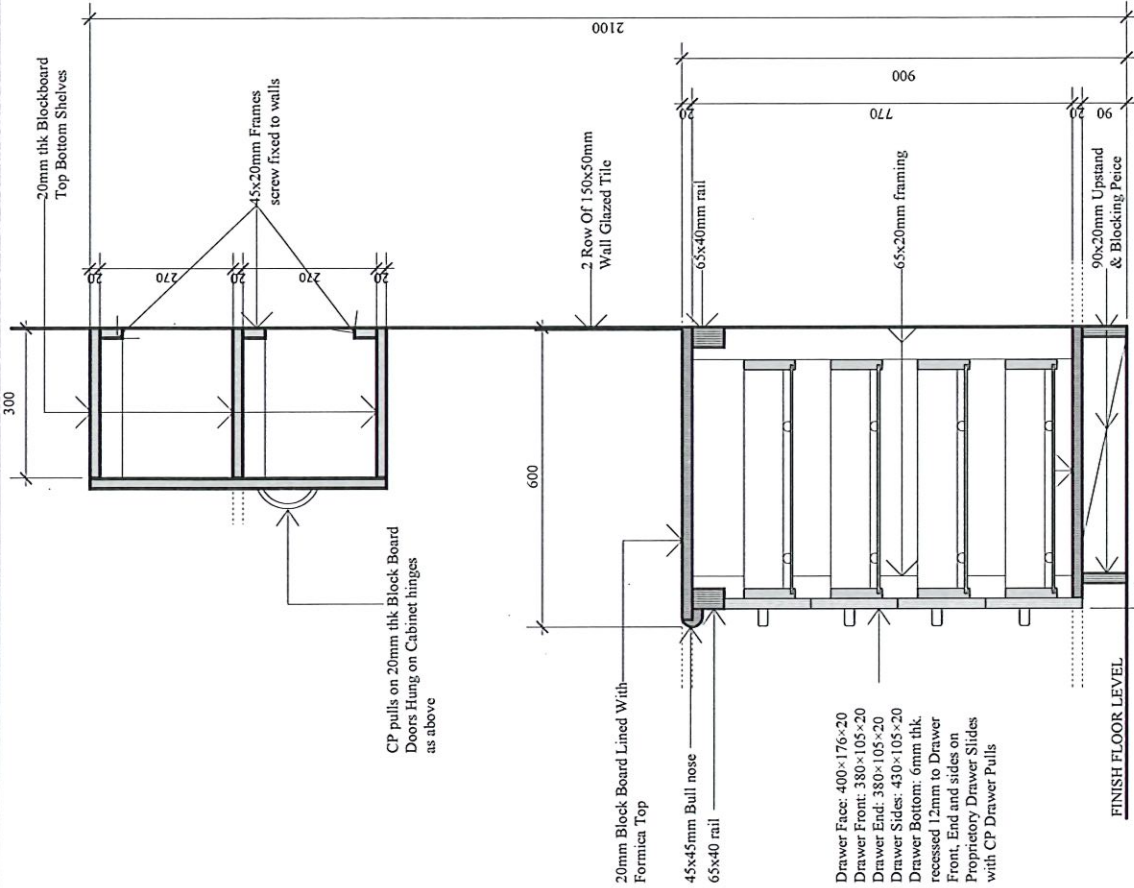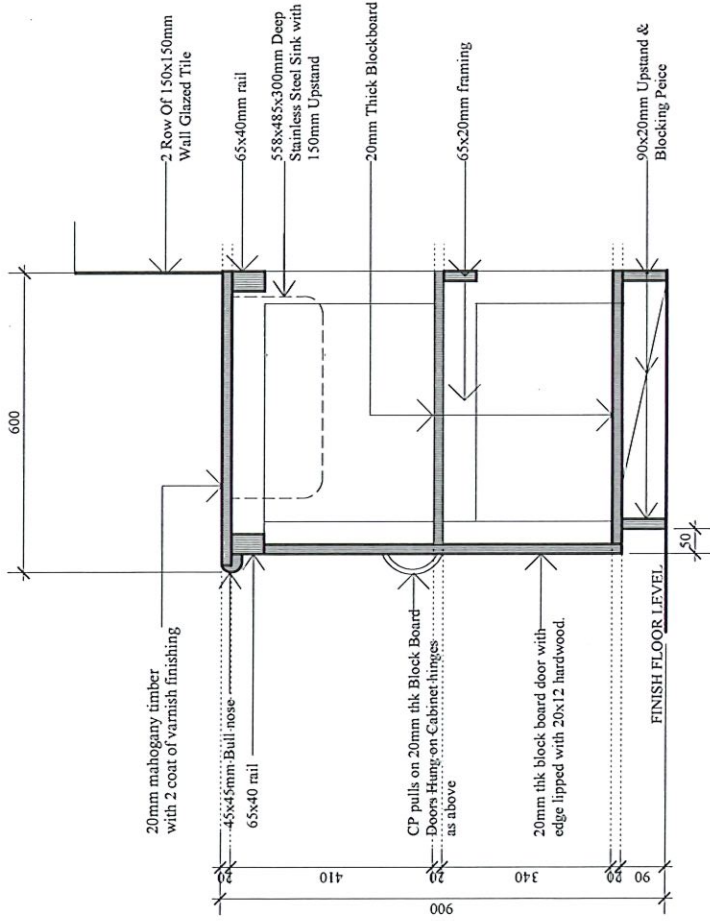

J2 IN-BUILT SINK BENCH DETAIL

Scale: 1:10

J3 OVERHEAD SHELVES/ DRAWERS DETAIL

Scale: 1:10

Amendment		drawn		date		proj/block		location no.		project no.	
The contractor must verify all dimensions on the drawing before the execution of work or shop drawings.		V.C / A.C		11 NOV 2024		Proposed Refurbishment and Alteration Works				23182	
The contractor shall notify the project architect of any discrepancies.		scale: as shown		V.CHAND		For Lautoka Legal Aid Office @ Lautoka.					
Figured dimensions shall take preference over scaled dimensions and the largest scale drawing will take preference.		AS SHOWN		DBCA approval							
Copyright of all specifications, documentation and all work executed pertaining to these documents remains the sole property of the Government Architects of the Republic of Fiji.		approval		C.TAWAKE							
Contractor to comply with all relevant Standards & relevant Regulations.						IN- BUILT SINK BENCH		A6.01			
						OVERHEAD SHELVES / DRAWERS DETAIL				amend	